


Last saved by: KAREN CRAMFORD (2022.11.15) | Last Plotted: 2023.11.15
 Filename: \\NA-AECOM\NET\COM\FS\EMEA\DU\IN\EDBLZ\LEGACY\IE\B\2\FP001\DATA\DCS\PROJECTS\BP\60648061_LDA_STG_TERRASAS\900_CAD_GIS\906_LAV02_SHEETS\STG-AEC-S1b-00-00-DR-L-0005001_LANDSCAPE SECTION SHEET.DWG
 Project Management Initials: Drawn by: KC Checked: RM Approved: PG
 ISO A1 594mm x 841mm

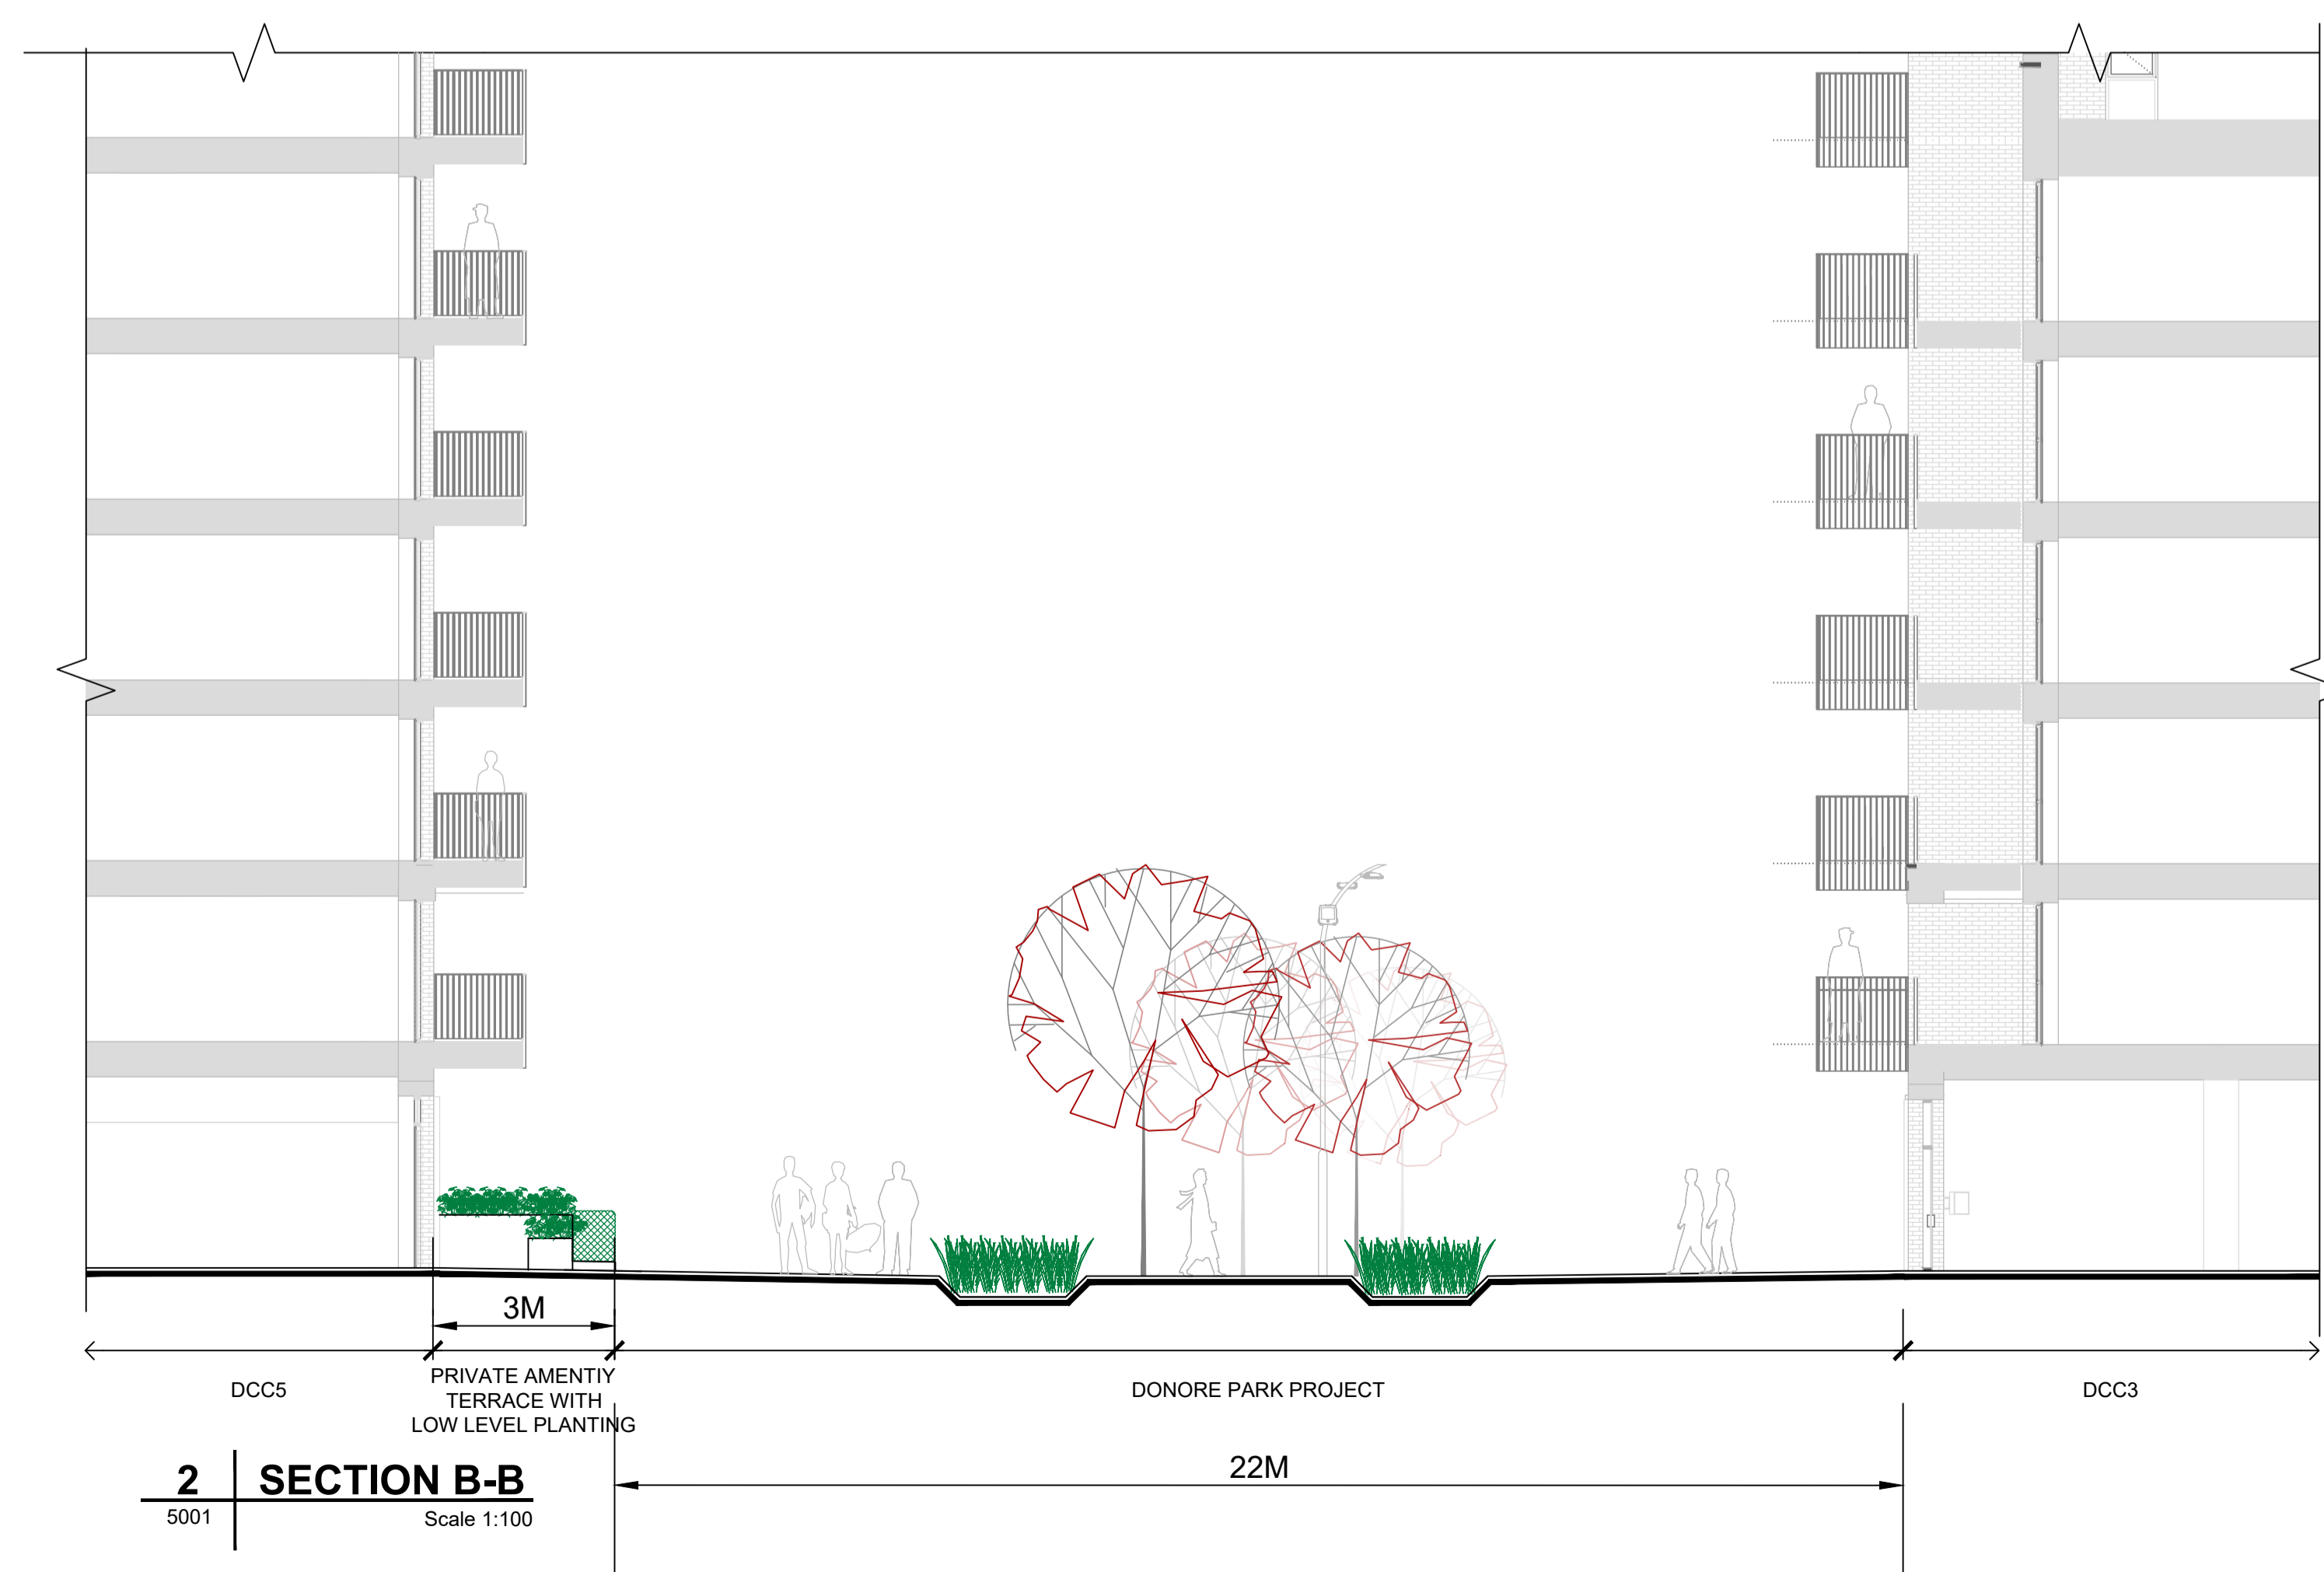


PROJECT
DONORE PROJECT,
DONORE AVENUE,
DUBLIN 8.

CLIENT
THE LAND DEVELOPMENT AGENCY

CONSULTANT
AECOM
4th Floor Adelphi Plaza,
George's Street Upper,
Dun Laoghaire,
Co Dublin
Tel: +353 (0)1 696-6220
www.aecom.com

- NOTES**
- THIS DRAWING IS TO BE READ IN CONJUNCTION WITH ALL OTHER RELEVANT ARCHITECTURAL AND ENGINEERING DRAWINGS. ANY DISCREPANCIES, ERRORS OR OMISSIONS TO BE BROUGHT TO THE ATTENTION OF THE DESIGNER.
 - ALL DIMENSIONS TO BE CHECKED BY THE CONTRACTOR ON SITE PRIOR TO COMMENCEMENT OF WORKS.
 - AECOM LIMITED TO BE INFORMED BY THE CONTRACTOR OF ANY DISCREPANCIES PRIOR TO THE COMMENCEMENT OF WORKS ON SITE.
 - DIMENSIONS OF ALL BOUNDARIES AND ADJOINING ROADS TO BE CHECKED ON SITE PRIOR TO COMMENCEMENT OF WORKS.
 - FOR WATERMAIN LAYOUT REFER TO DRAWING STG-AEC-S1b-00-00-DR-C-0002700.
 - FOR DRAINAGE LAYOUT REFER TO DRAWING STG-AEC-S1b-00-00-DR-C-0000501.

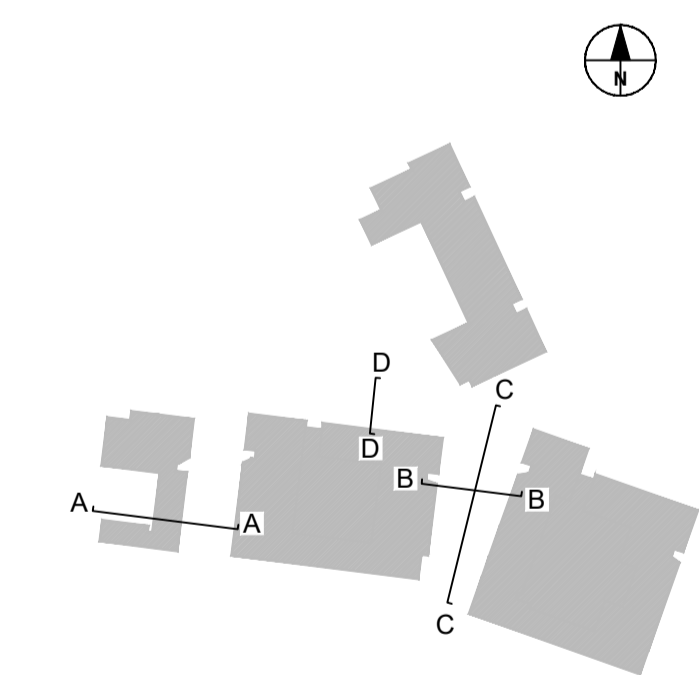

ISSUE/REVISION

| I/R | DATE | DESCRIPTION |
|-----|----------|---------------------|
| P1 | DEC 2022 | ISSUED FOR PLANNING |

PROJECT NUMBER
60648061

SHEET TITLE
LANDSCAPE SECTIONS
SHEET 1 OF 2

SHEET NUMBER
STG-AEC-S1b-00-00-DR-L-0005001

This drawing has been prepared for the use of AECOM's client. It may not be used, modified, reproduced or relied upon by third parties, except as agreed by AECOM or as required by law. AECOM accepts no responsibility, and denies any liability whatsoever, to any party that uses or relies on this drawing without AECOM's express written consent. Do not scale this document. All measurements must be obtained from the stated dimensions.